


REVISIONS	BY
8-16-99	RCM
9-20-99	RCM


KERRY E. SOLOMON ARCHITECTS, INC.
 624 ROCK SPRINGS ROAD
 PITTSBURGH, PENNSYLVANIA 15228
 (412) 563-7656 FAX (412) 563-0786

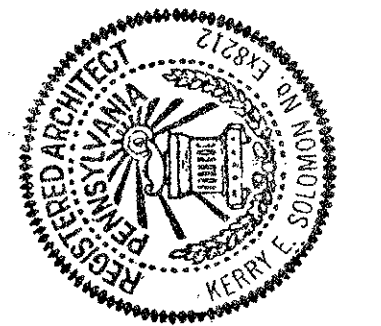


PROPOSED CINEMA COMPLEX
 FOR
 KLM THEATRE PARTNERS, L.P. D.B.A.
STAR CITY
 ROUTE 50 SOUTH FAYETTE, PA

DRAWN RCM
CHECKED KES
DATE 8-9-99
SCALE 1/16" = 1'-0"
JOB NO. 9929
SHEET
A1.1
OF SHEETS

COPYRIGHT © 1999
 KERRY E. SOLOMON ARCHT
 ALL RIGHTS RESERVED

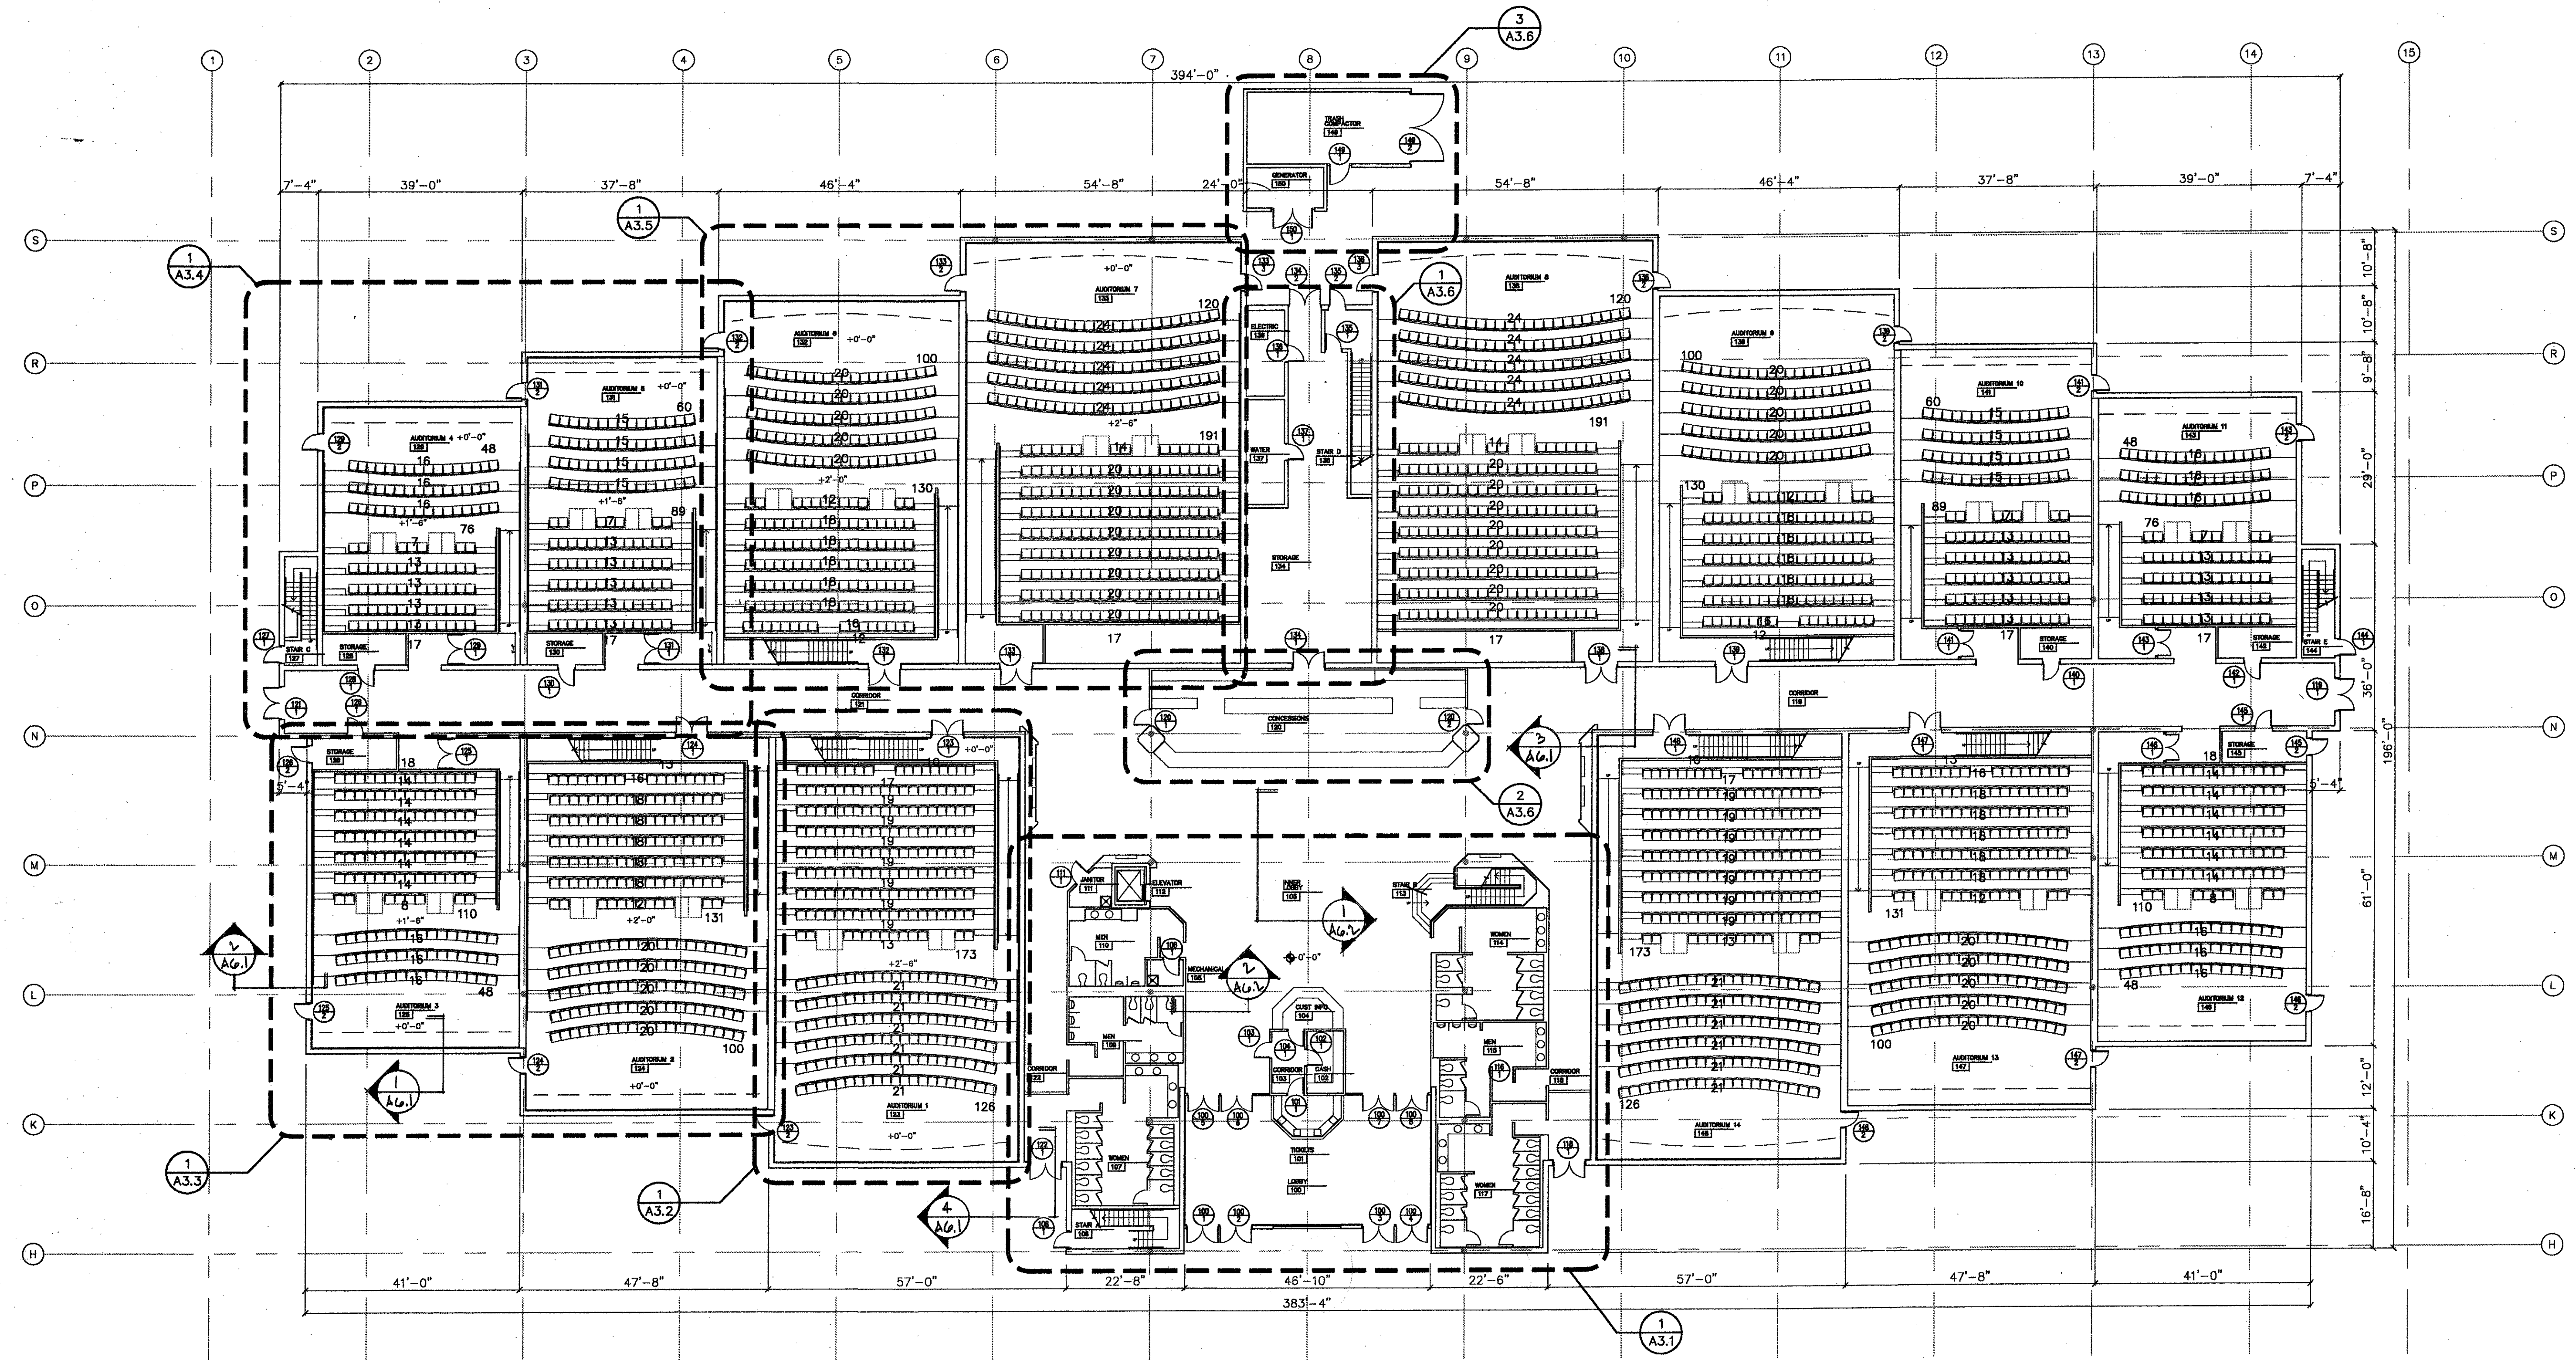

FIRST FLOOR PLAN 62,025 S.F.
 1/16" = 1'-0" TOTAL SEATS: 3004 PLUS 60 HC

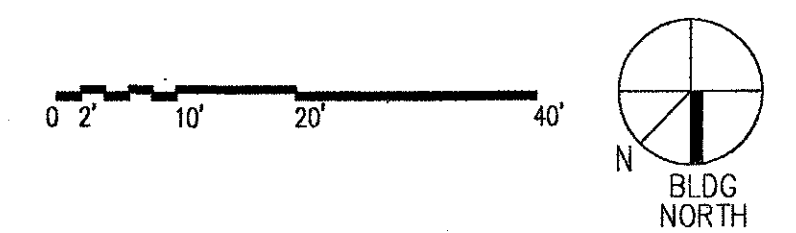

NOTE: COLUMN CENTERLINES/GRID ARE BASED ON EXISTING SYSTEM ESTABLISHED FOR MULACH STEEL BUILDING WHICH FORMERLY OCCUPIED THE SITE.