



REVISIONS	BY
8-16-99	RCM
9-20-99	RCM

KERRY E. SOLOMON ARCHITECTS, INC.
 624 ROCK SPRINGS ROAD
 PITTSBURGH, PENNSYLVANIA 15228
 (412) 563-7656 FAX (412) 563-0786

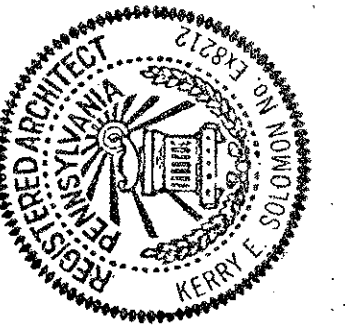

PROPOSED CINEMA COMPLEX
 FOR
 KLM THEATRE PARTNERS, L.P. D.B.A.
STAR CITY
 ROUTE 50 SOUTH FAYETTE, PA

DRAWN	RCM
CHECKED	KES
DATE	8-9-99
SCALE	1/16" = 1'-0"
JOB NO.	9929
SHEET	
A12	
OF	SHEETS

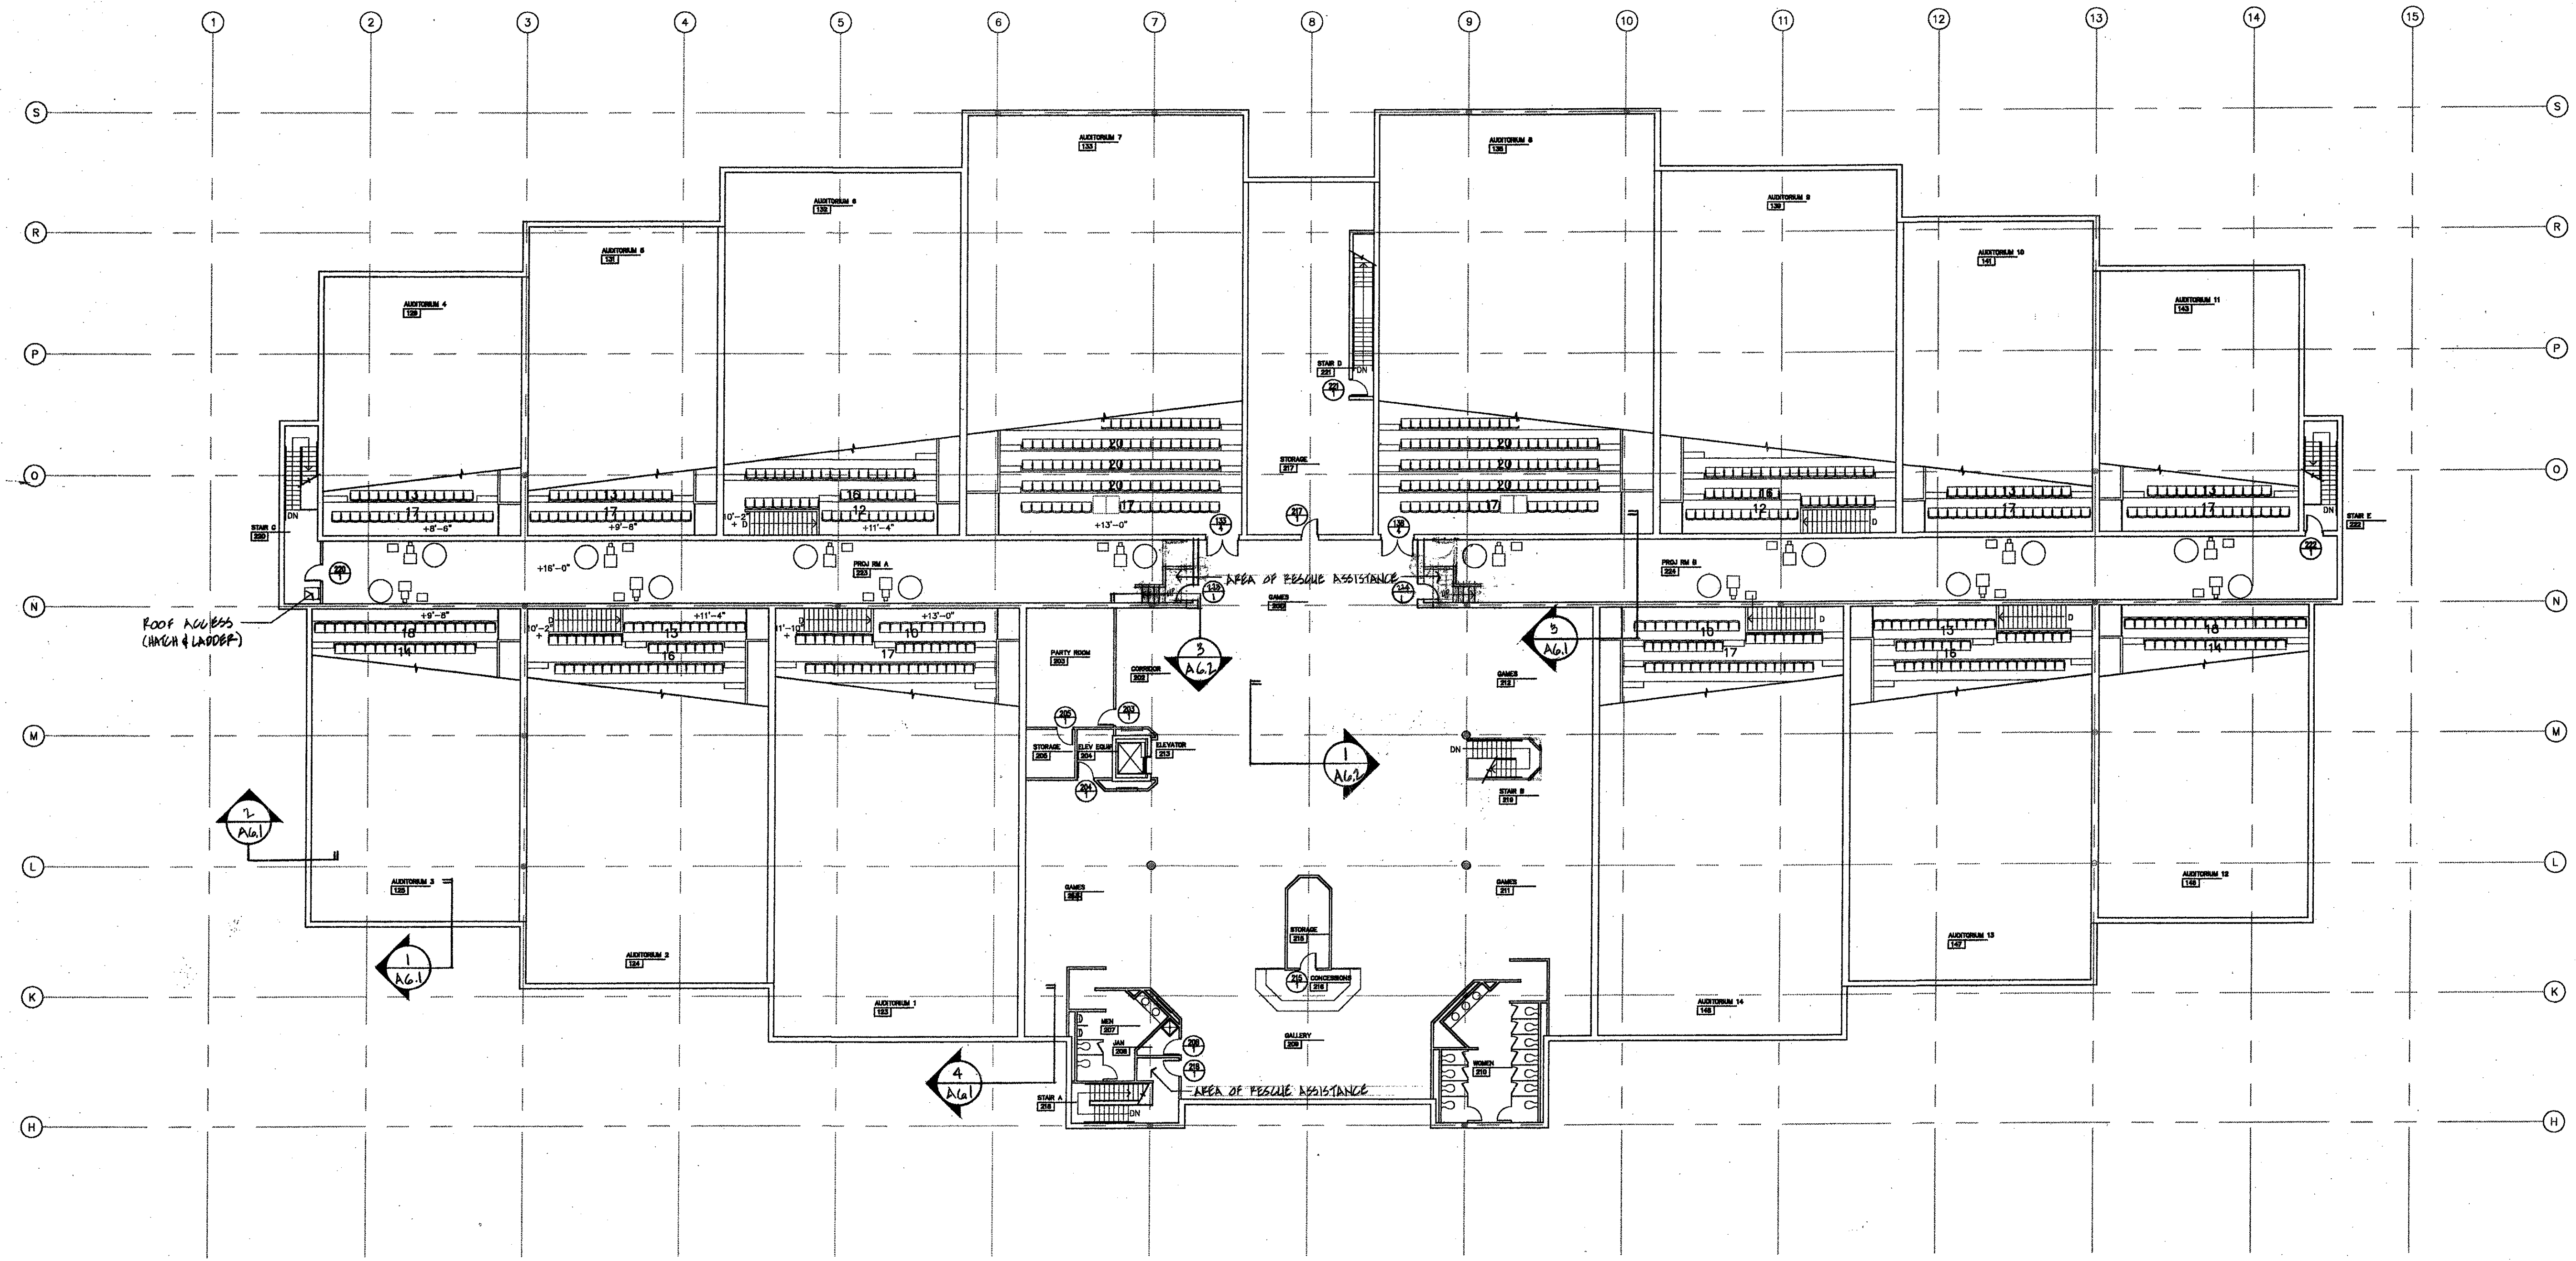

SECOND FLOOR PLAN 13,070 S.F.
 1/16" = 1'-0"

