


REVISIONS	BY


KERRY E. SOLOMON ARCHITECTS, INC.
 624 ROCK SPRINGS ROAD
 PITTSBURGH, PENNSYLVANIA 15228
 (412) 563-7656 FAX (412) 563-0786

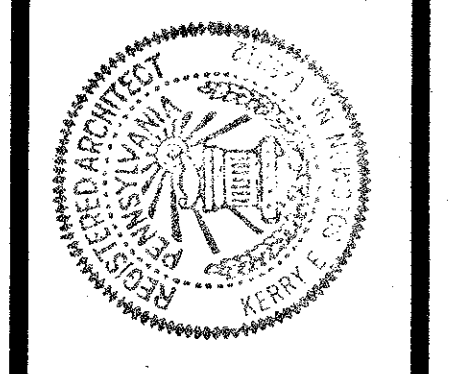

PROPOSED CINEMA COMPLEX
 FOR
 KLM THEATRE PARTNERS, L.P. D.B.A.
STAR CITY
 ROUTE 50 SOUTH FAYETTE, PA

DRAWN	KES/1006
CHECKED	KES
DATE	9-22-99
SCALE	3/4" = 1'-0"
JOB NO.	9929
SHEET	

AG.1
 OF SHEETS

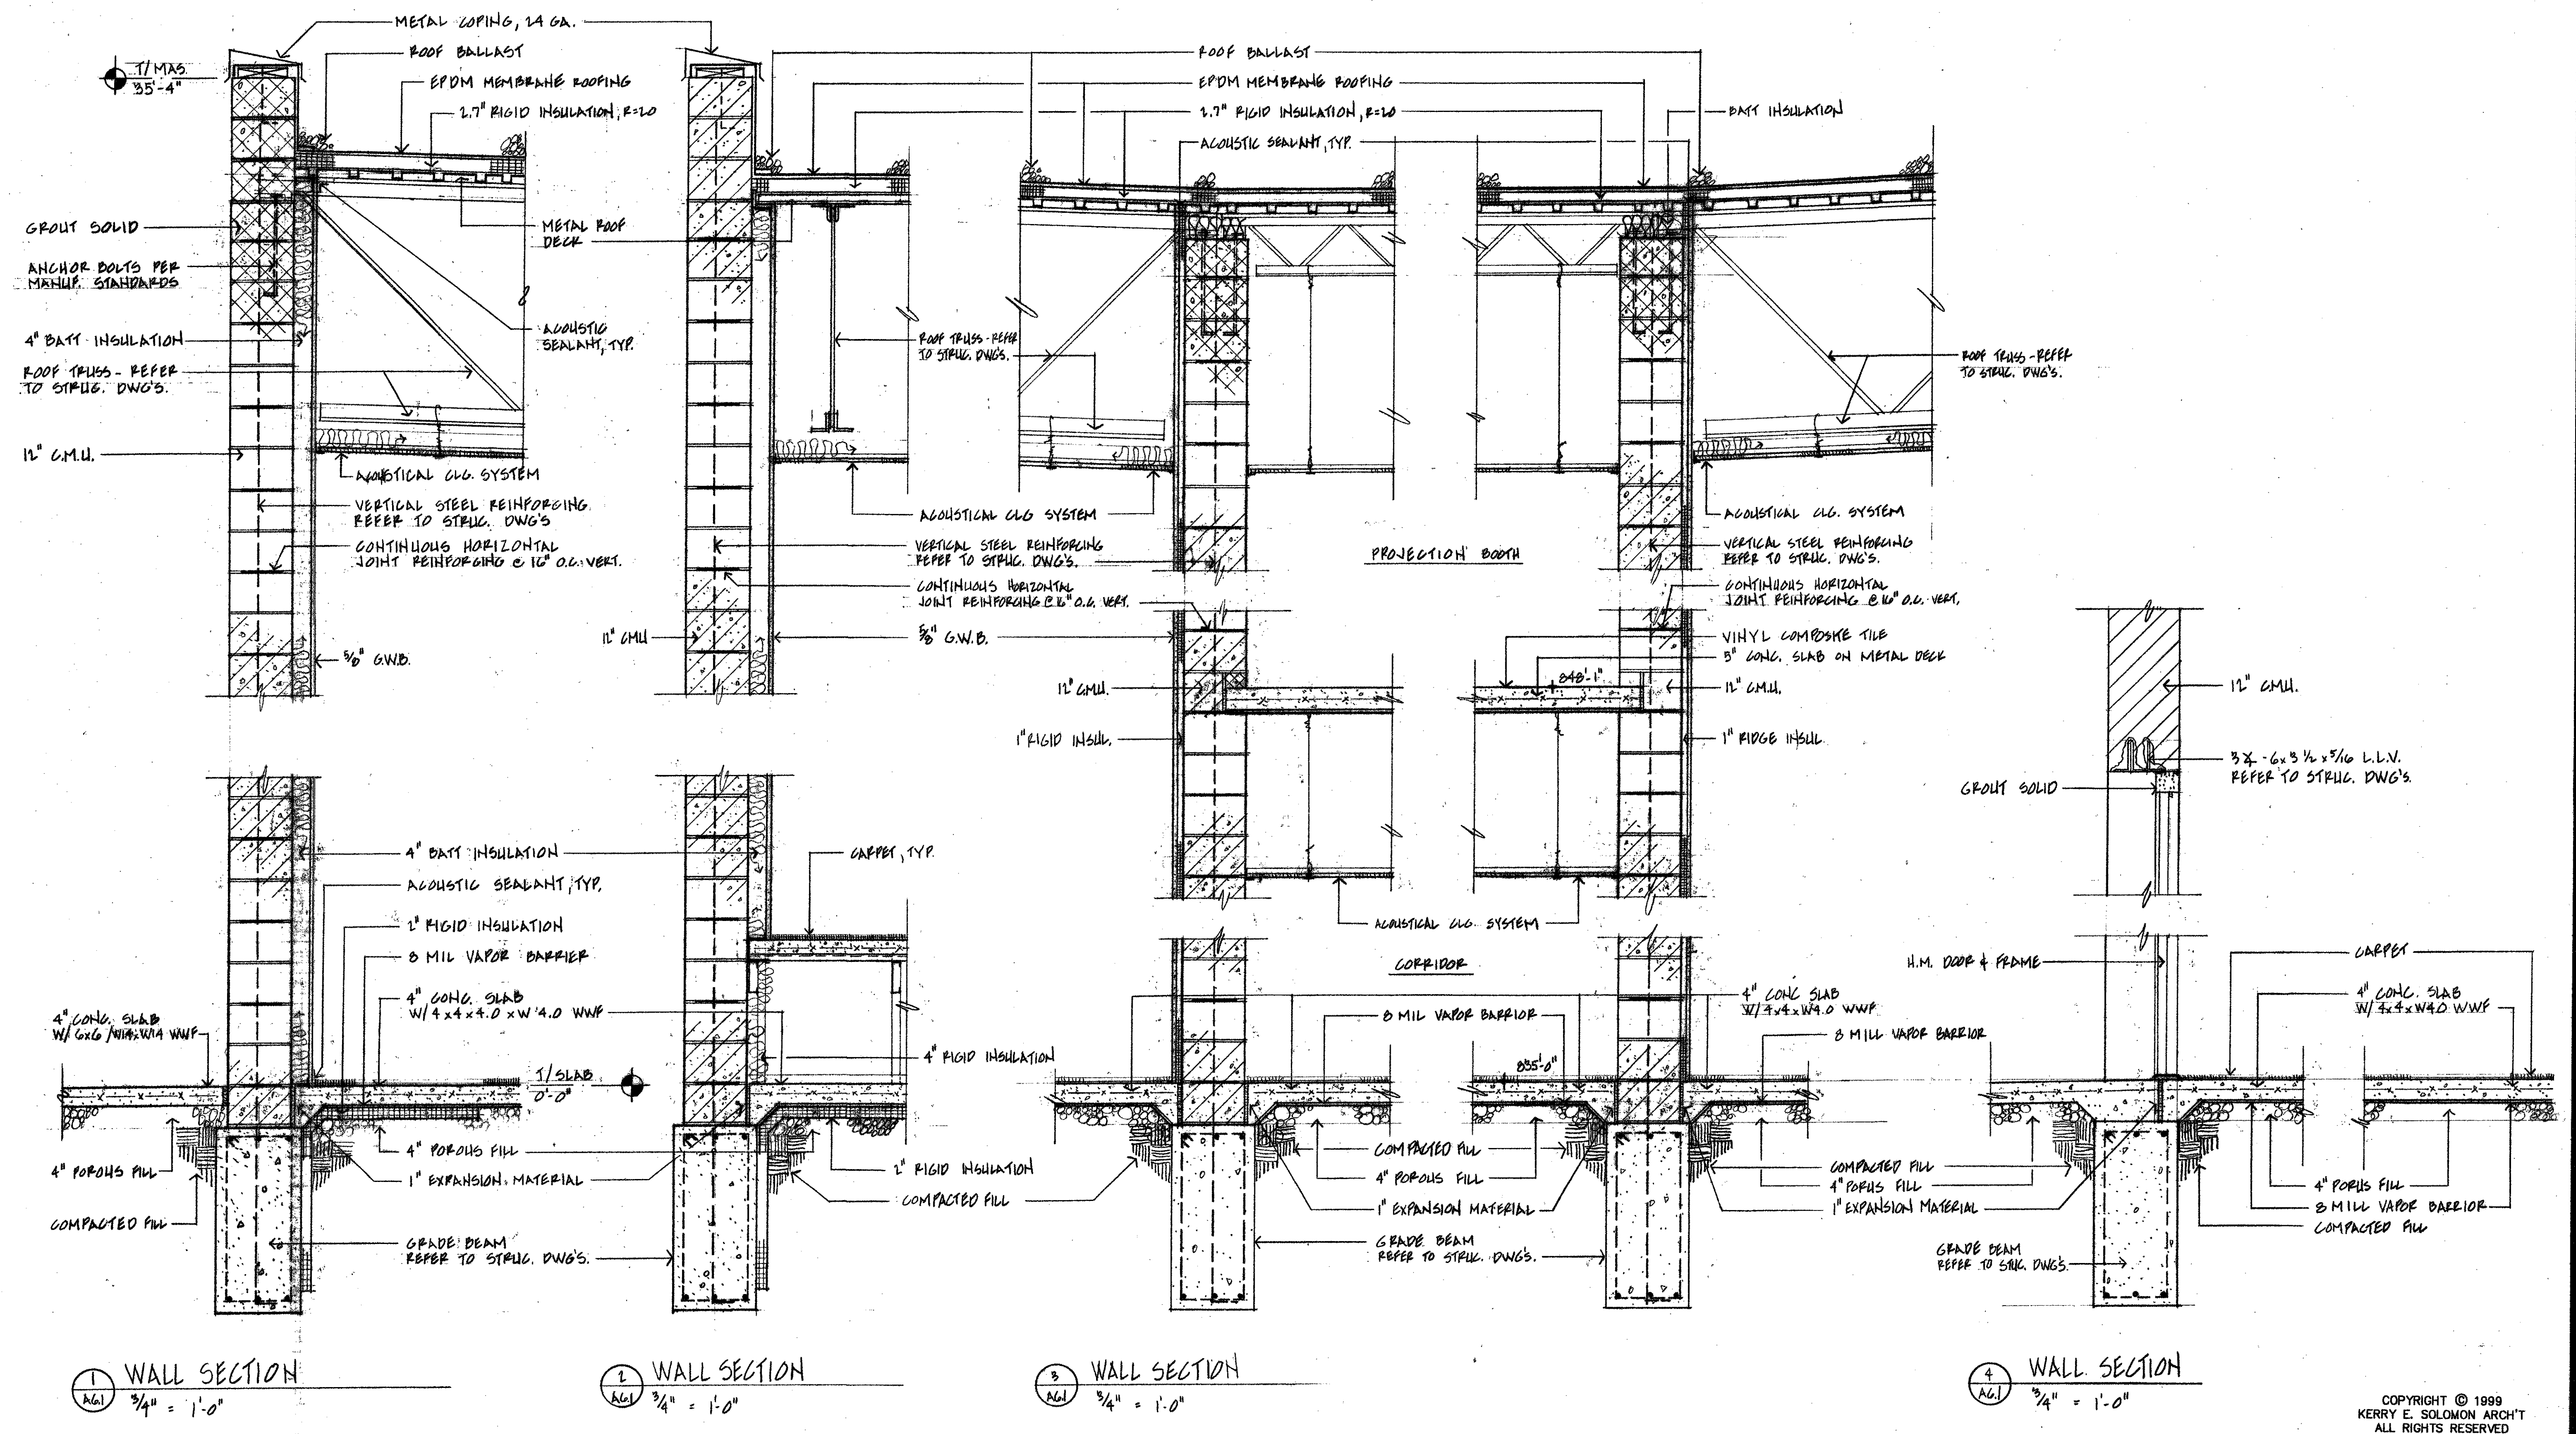

1 WALL SECTION
 3/4" = 1'-0"

2 WALL SECTION
 3/4" = 1'-0"

3 WALL SECTION
 3/4" = 1'-0"

4 WALL SECTION
 3/4" = 1'-0"

COPYRIGHT © 1999
 KERRY E. SOLOMON ARCHT
 ALL RIGHTS RESERVED